


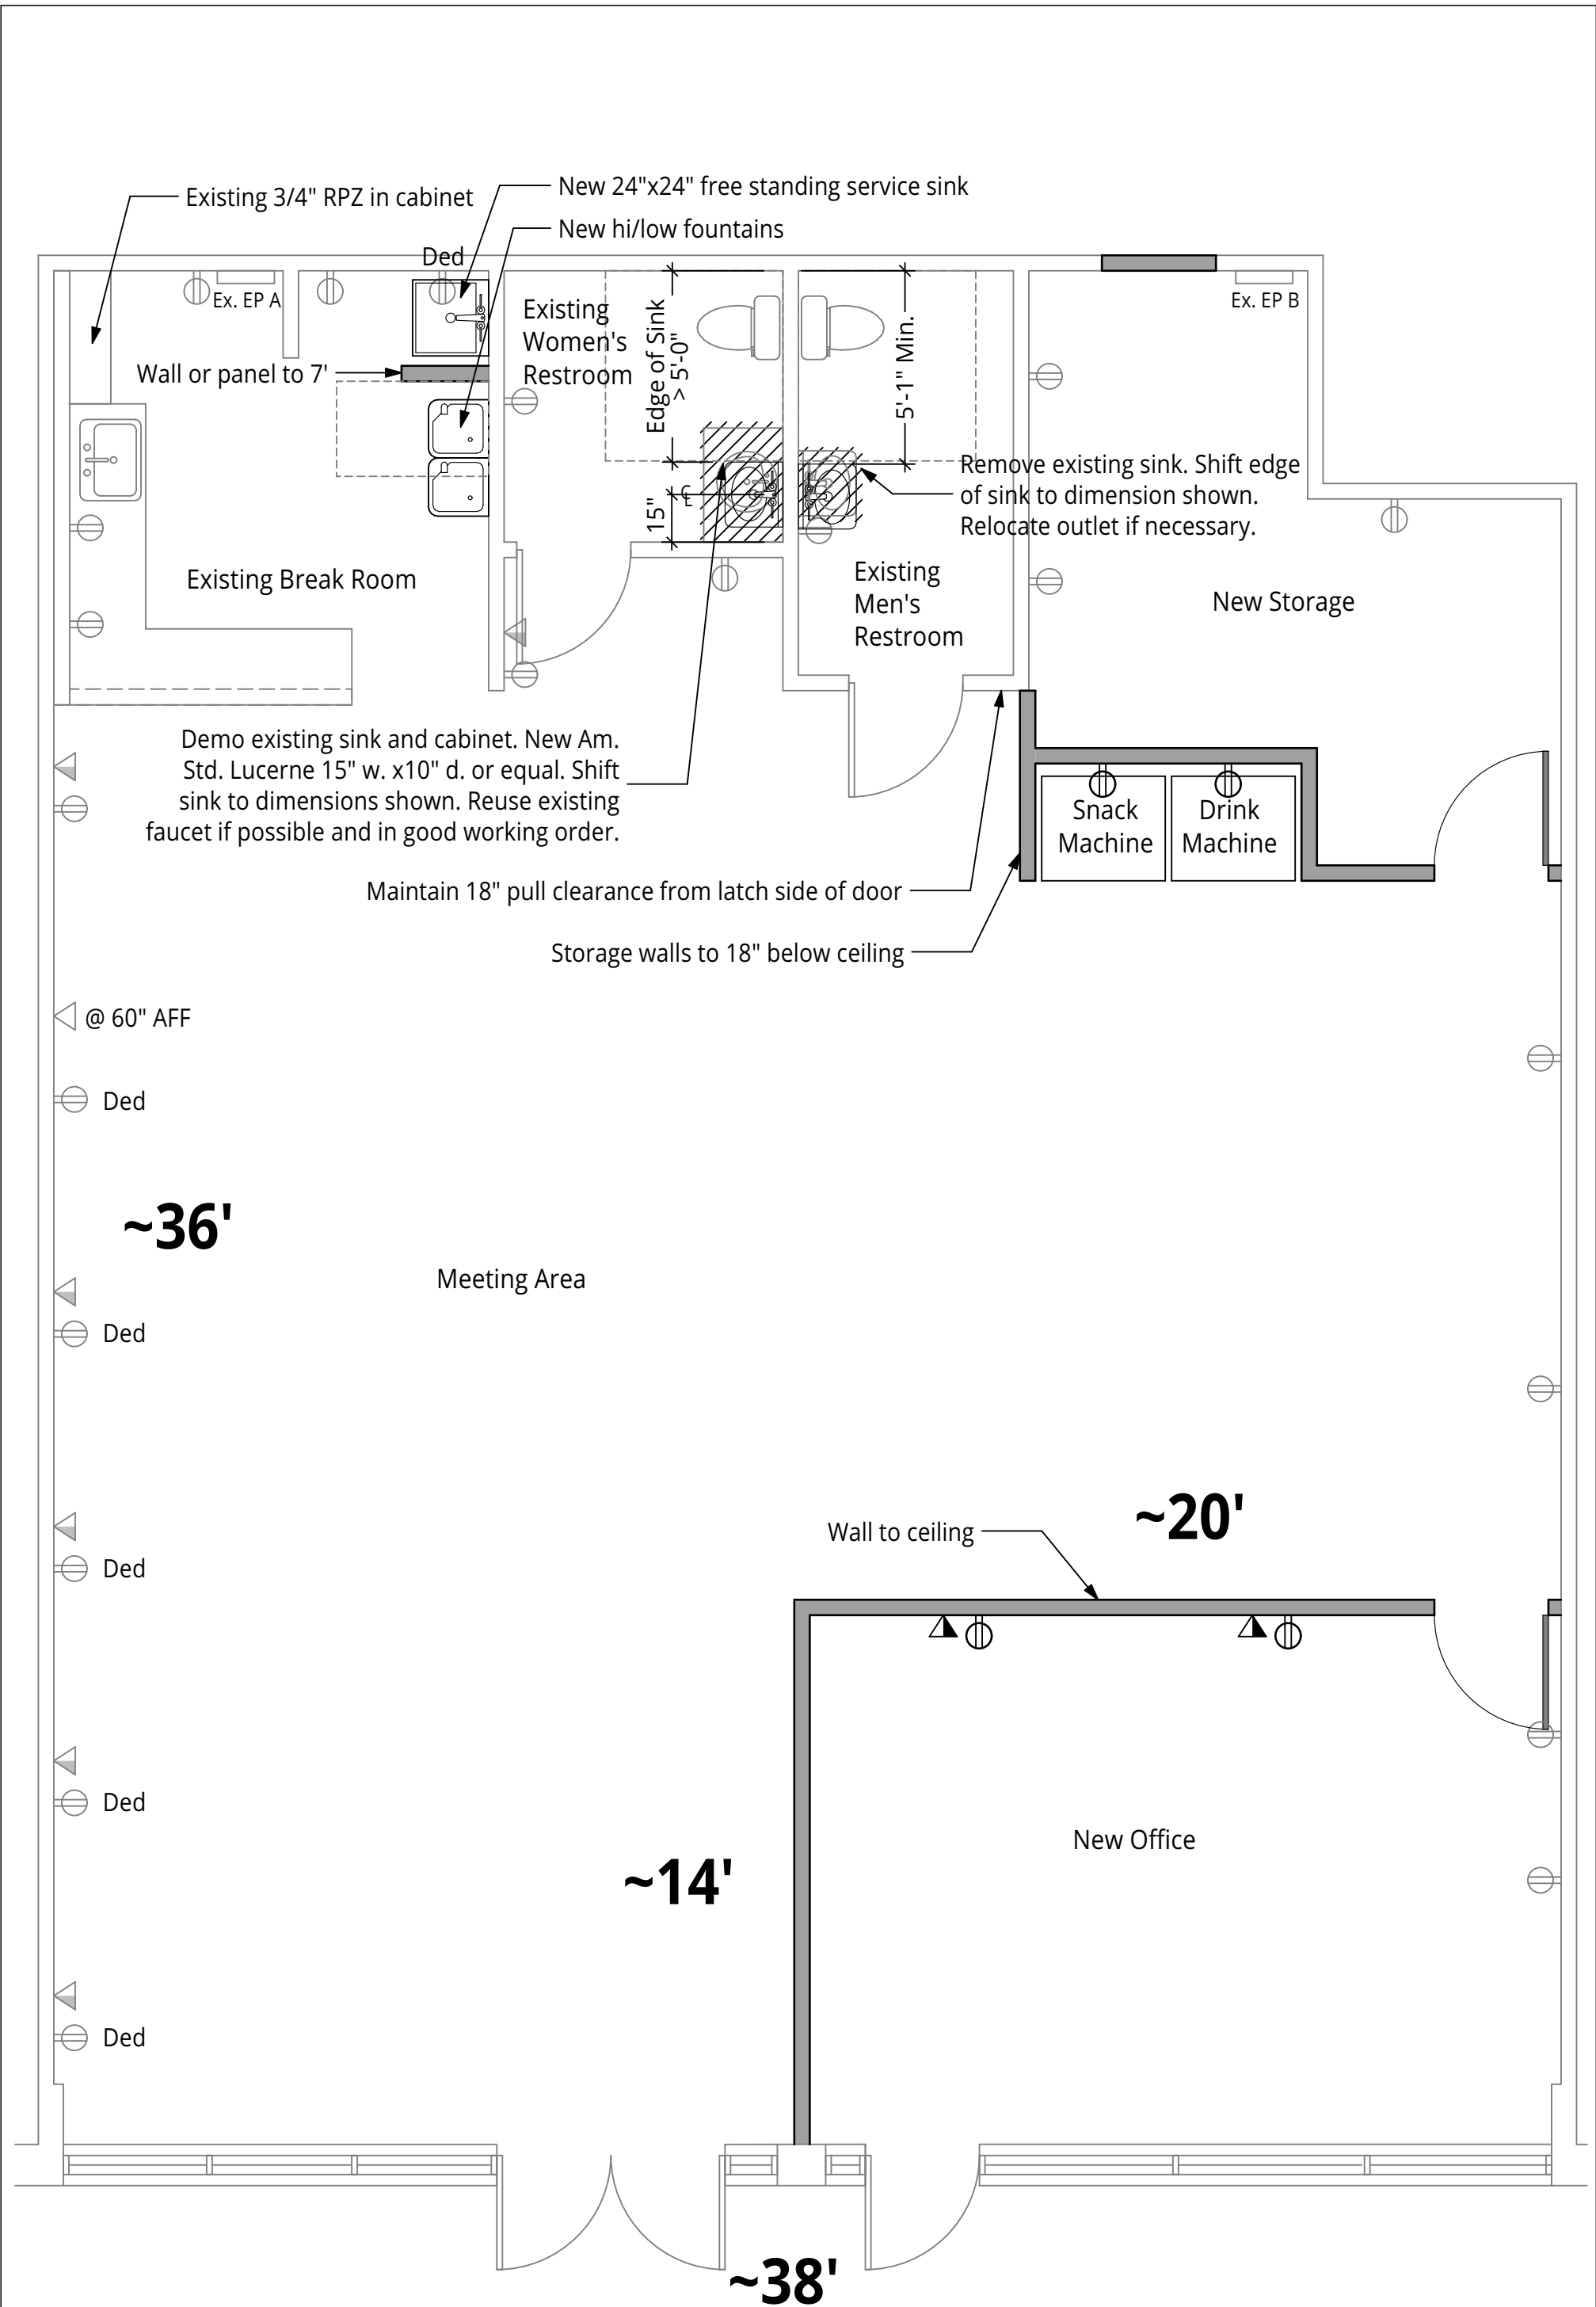

Electrical Plan

SCALE: 1/4" = 1'-0"

BNP Architecture, PLLC

P. O. Box 72153
Durham, NC 27722-2153
919.224.9700
brett@bnparchitecture.com

Triangle Alano Club Renovation

2825 Jones Franklin Road
Raleigh, NC 27608

For Review Only
Not For Construction

Scheme 2
Print Size to Scale: 11x17
Scale: As noted
Issued: 4/23/26